



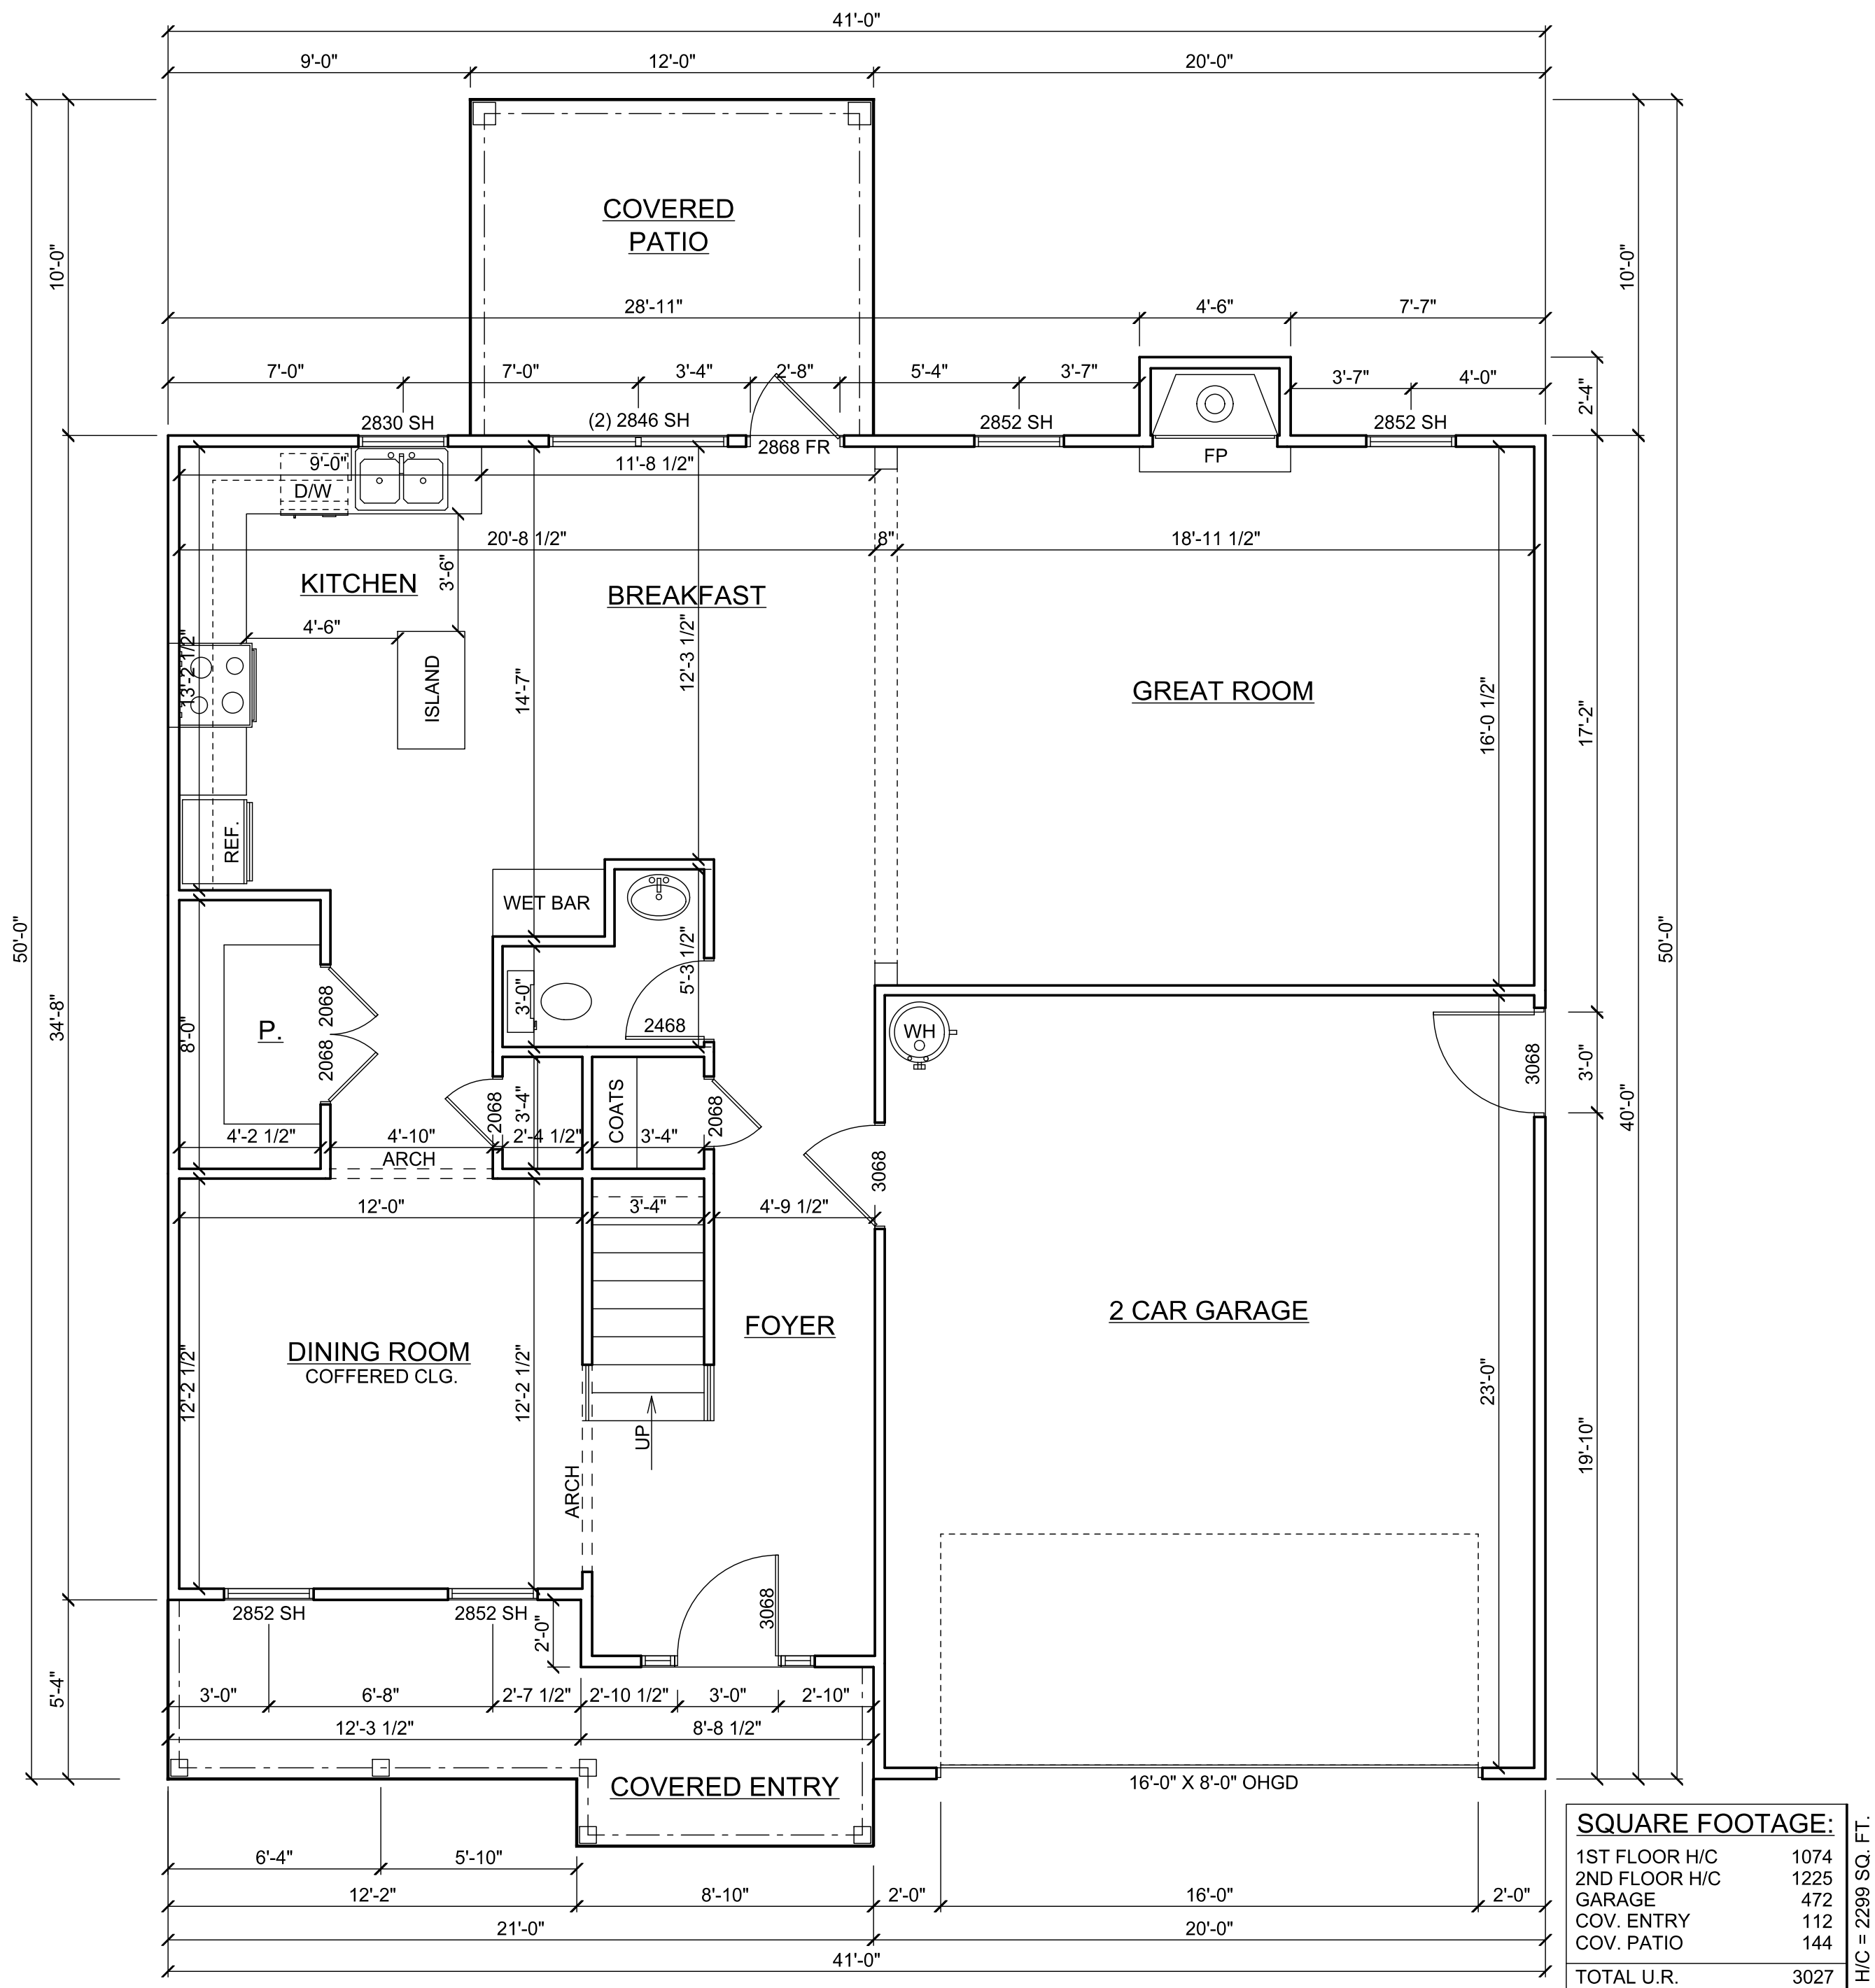

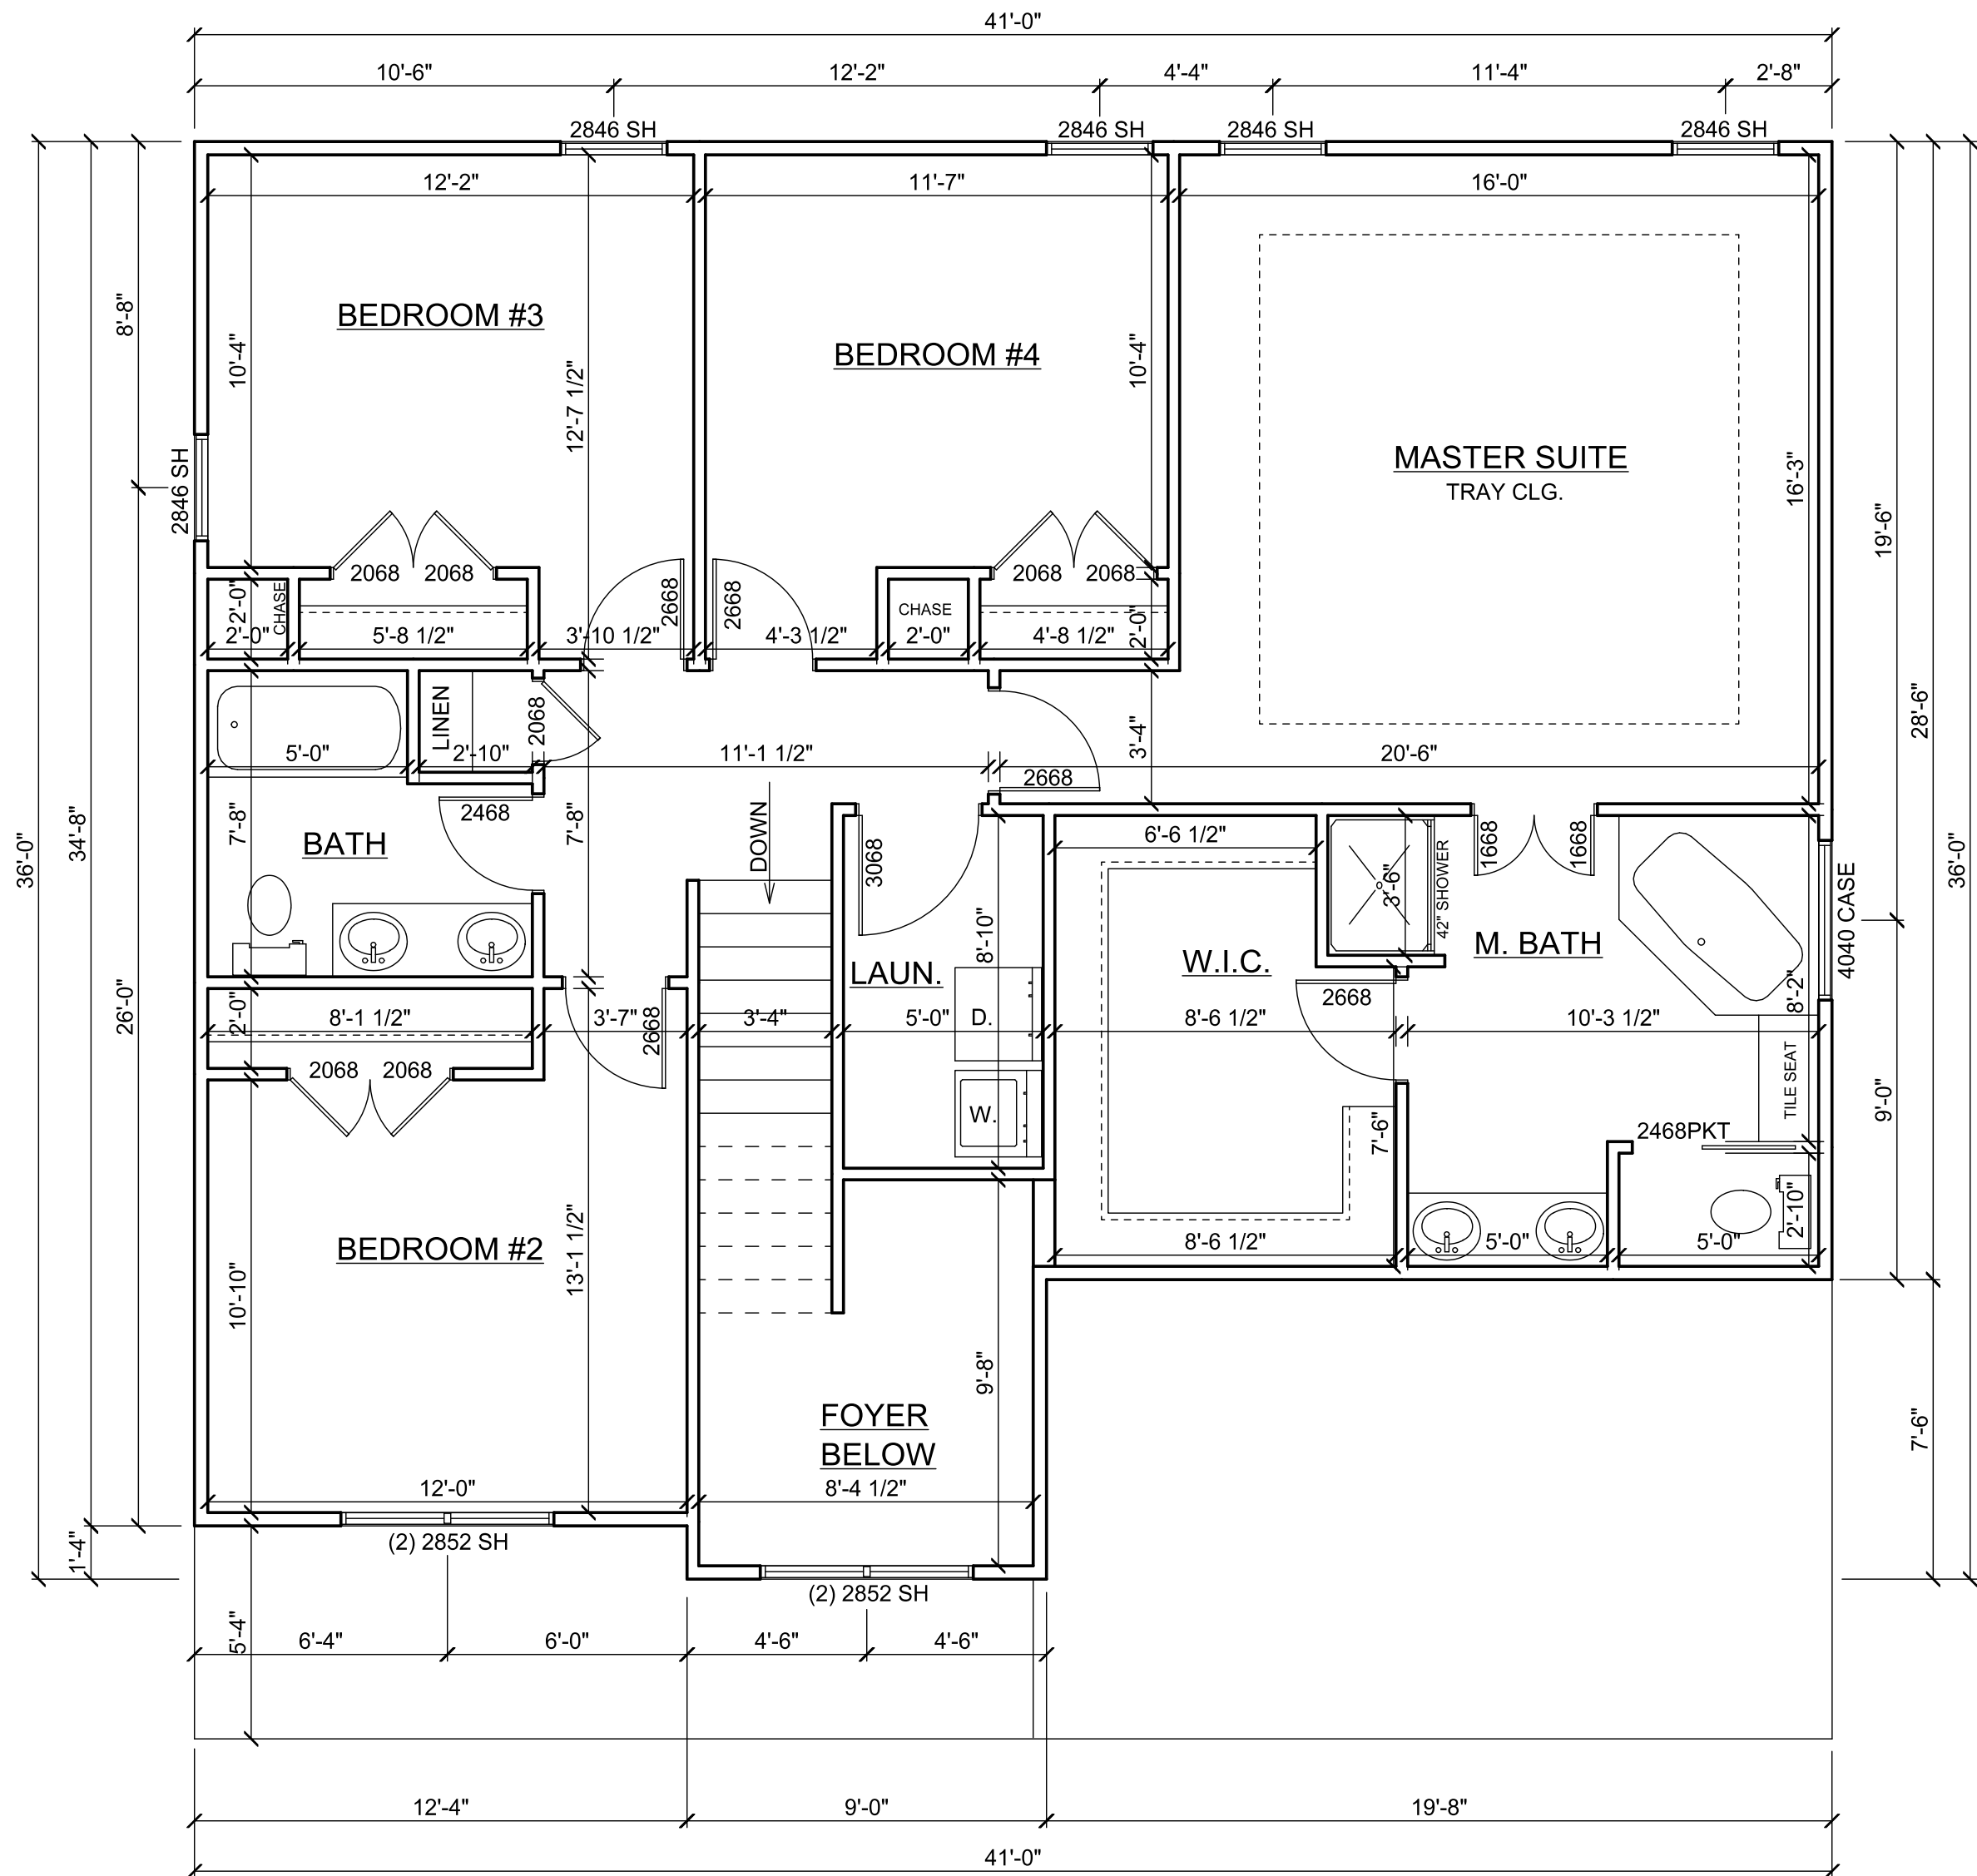

SECOND FLOOR PLAN
SCALE: 1/4" = 1'-0"

DATE: 12/02/2012
DRAWN: KD
CHECKED:

PROJECT
#1230

SHEET NUMBER

2
OF
8

A PROPOSED RESIDENCE FOR:
ALLEYNA MODEL

HORIZONS EAST, LLC

JACKSONVILLE, NC

(910) 346-9068

**VISUAL
CONCEPTS**
DRAFTING & DESIGN
(828) 649-7038



FRONT ELEVATION

SCALE: 1/4" = 1'-0"



REAR ELEVATION


SCALE: 1/4" = 1'-0"




RIGHT SIDE ELEVATION
SCALE: 1/4" = 1'-0"



LEFT SIDE ELEVATION
SCALE: 1/4" = 1'-0"


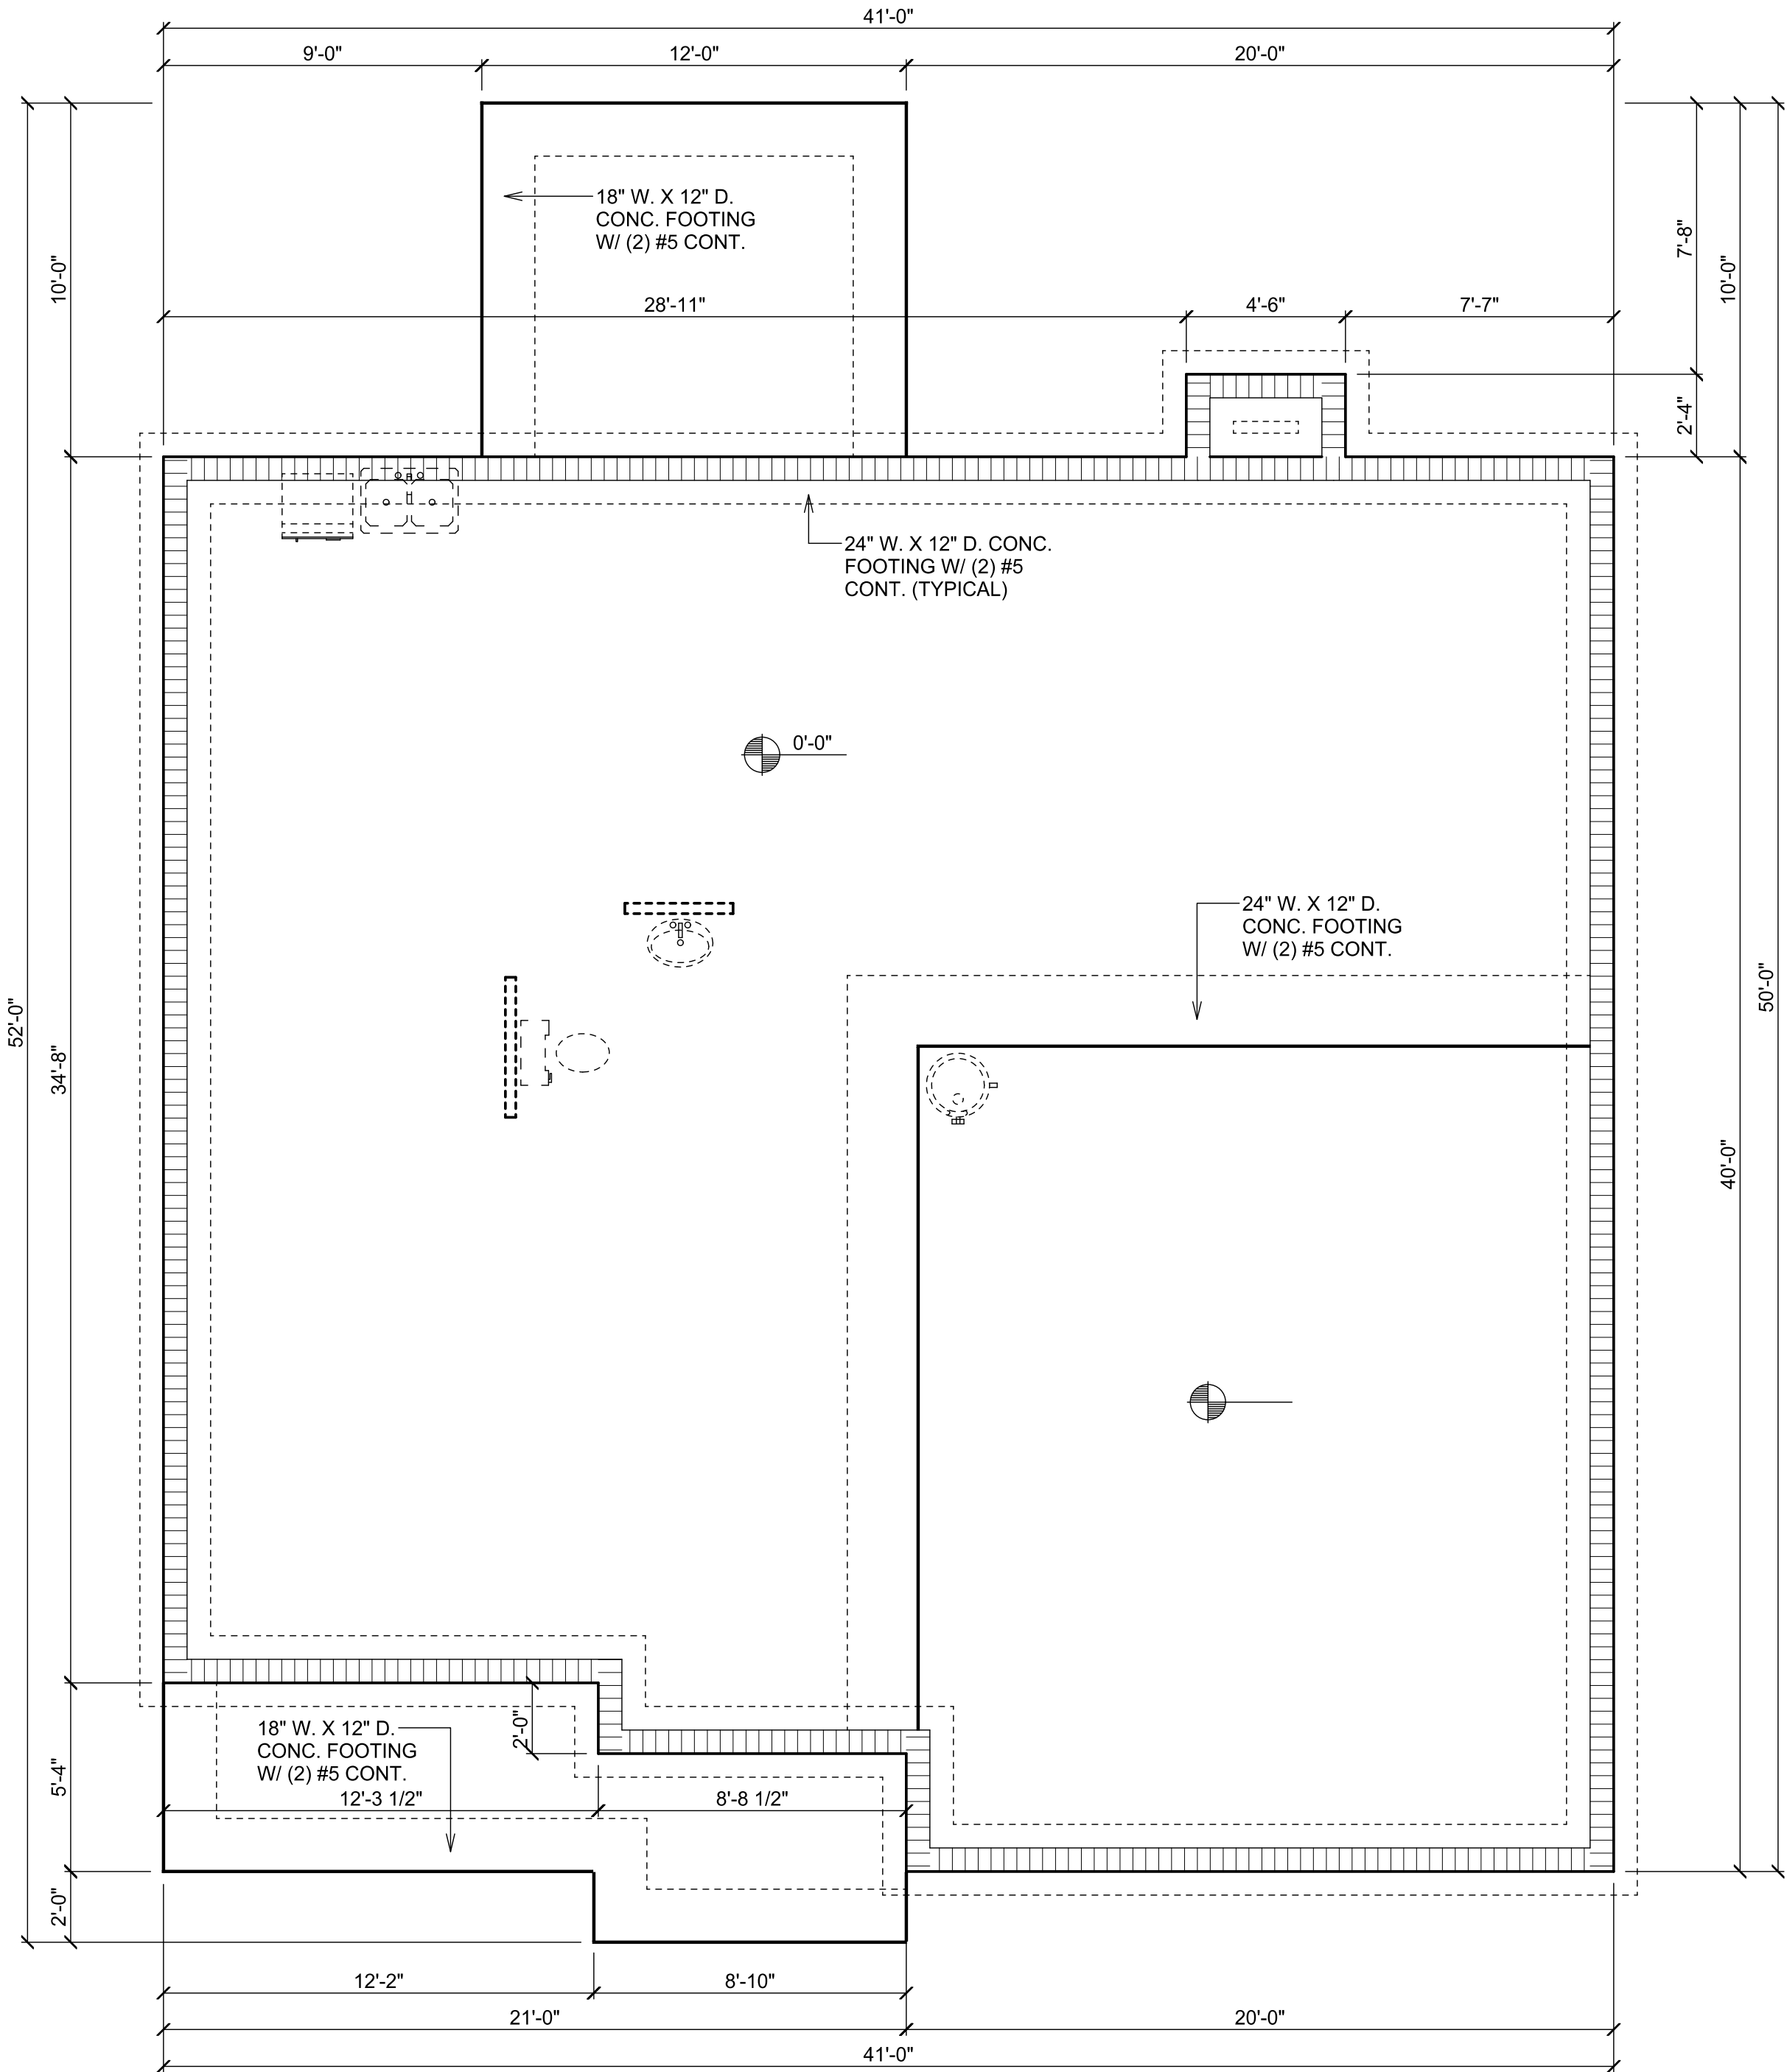


FOUNDATION PLAN
SCALE: 1/4" = 1'-0"

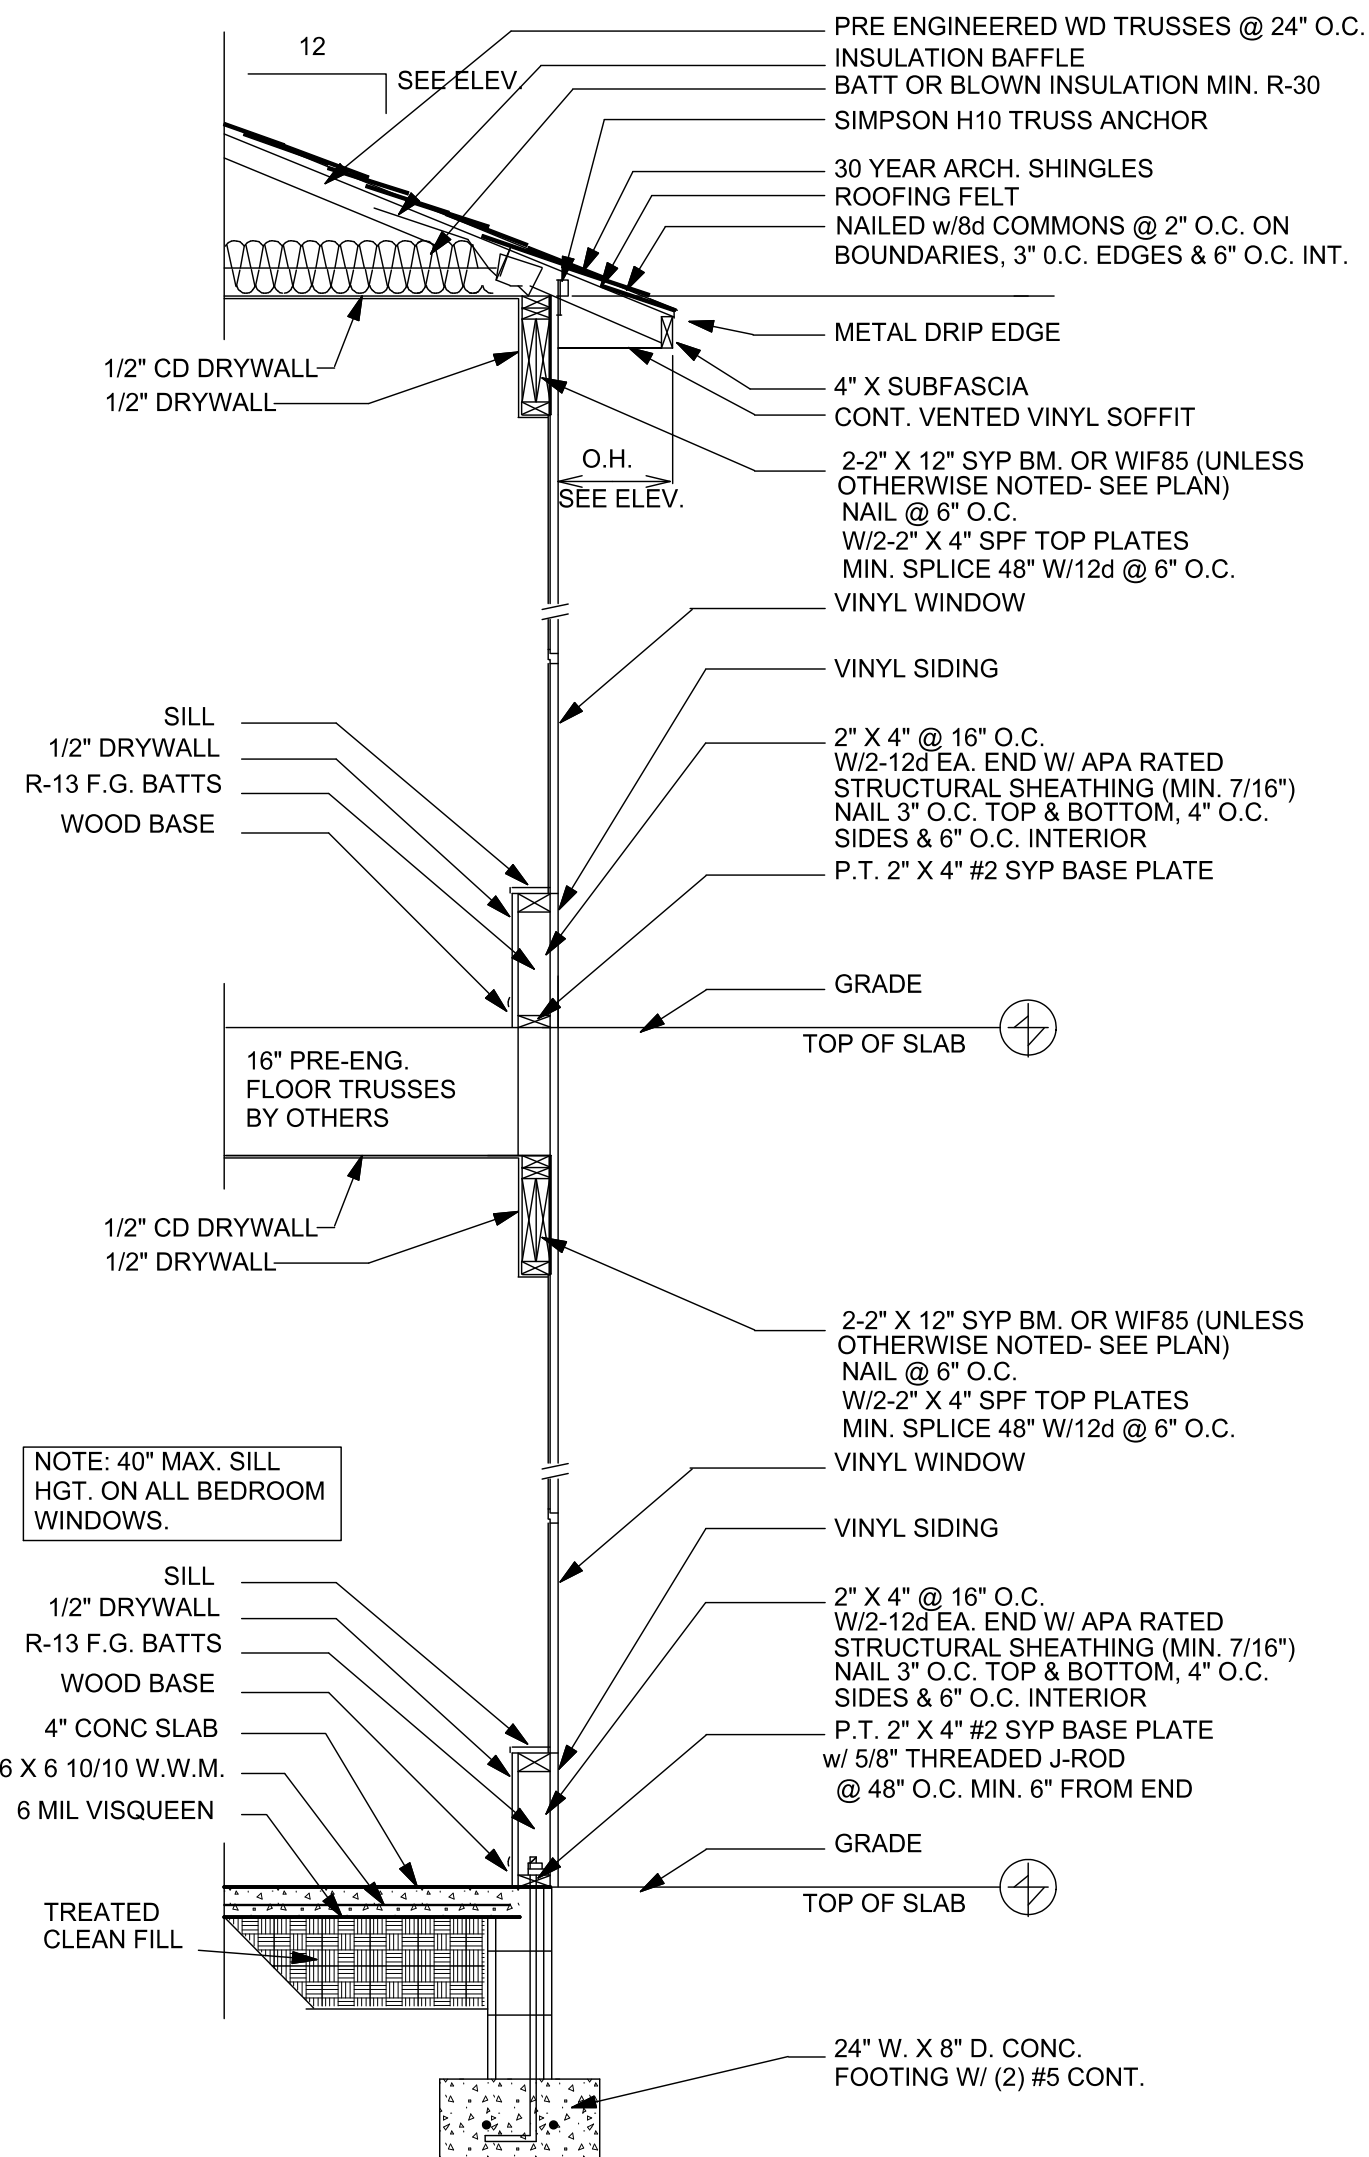

TYPICAL WALL SECTION
EXTERIOR FRAME

SCALE: NTS

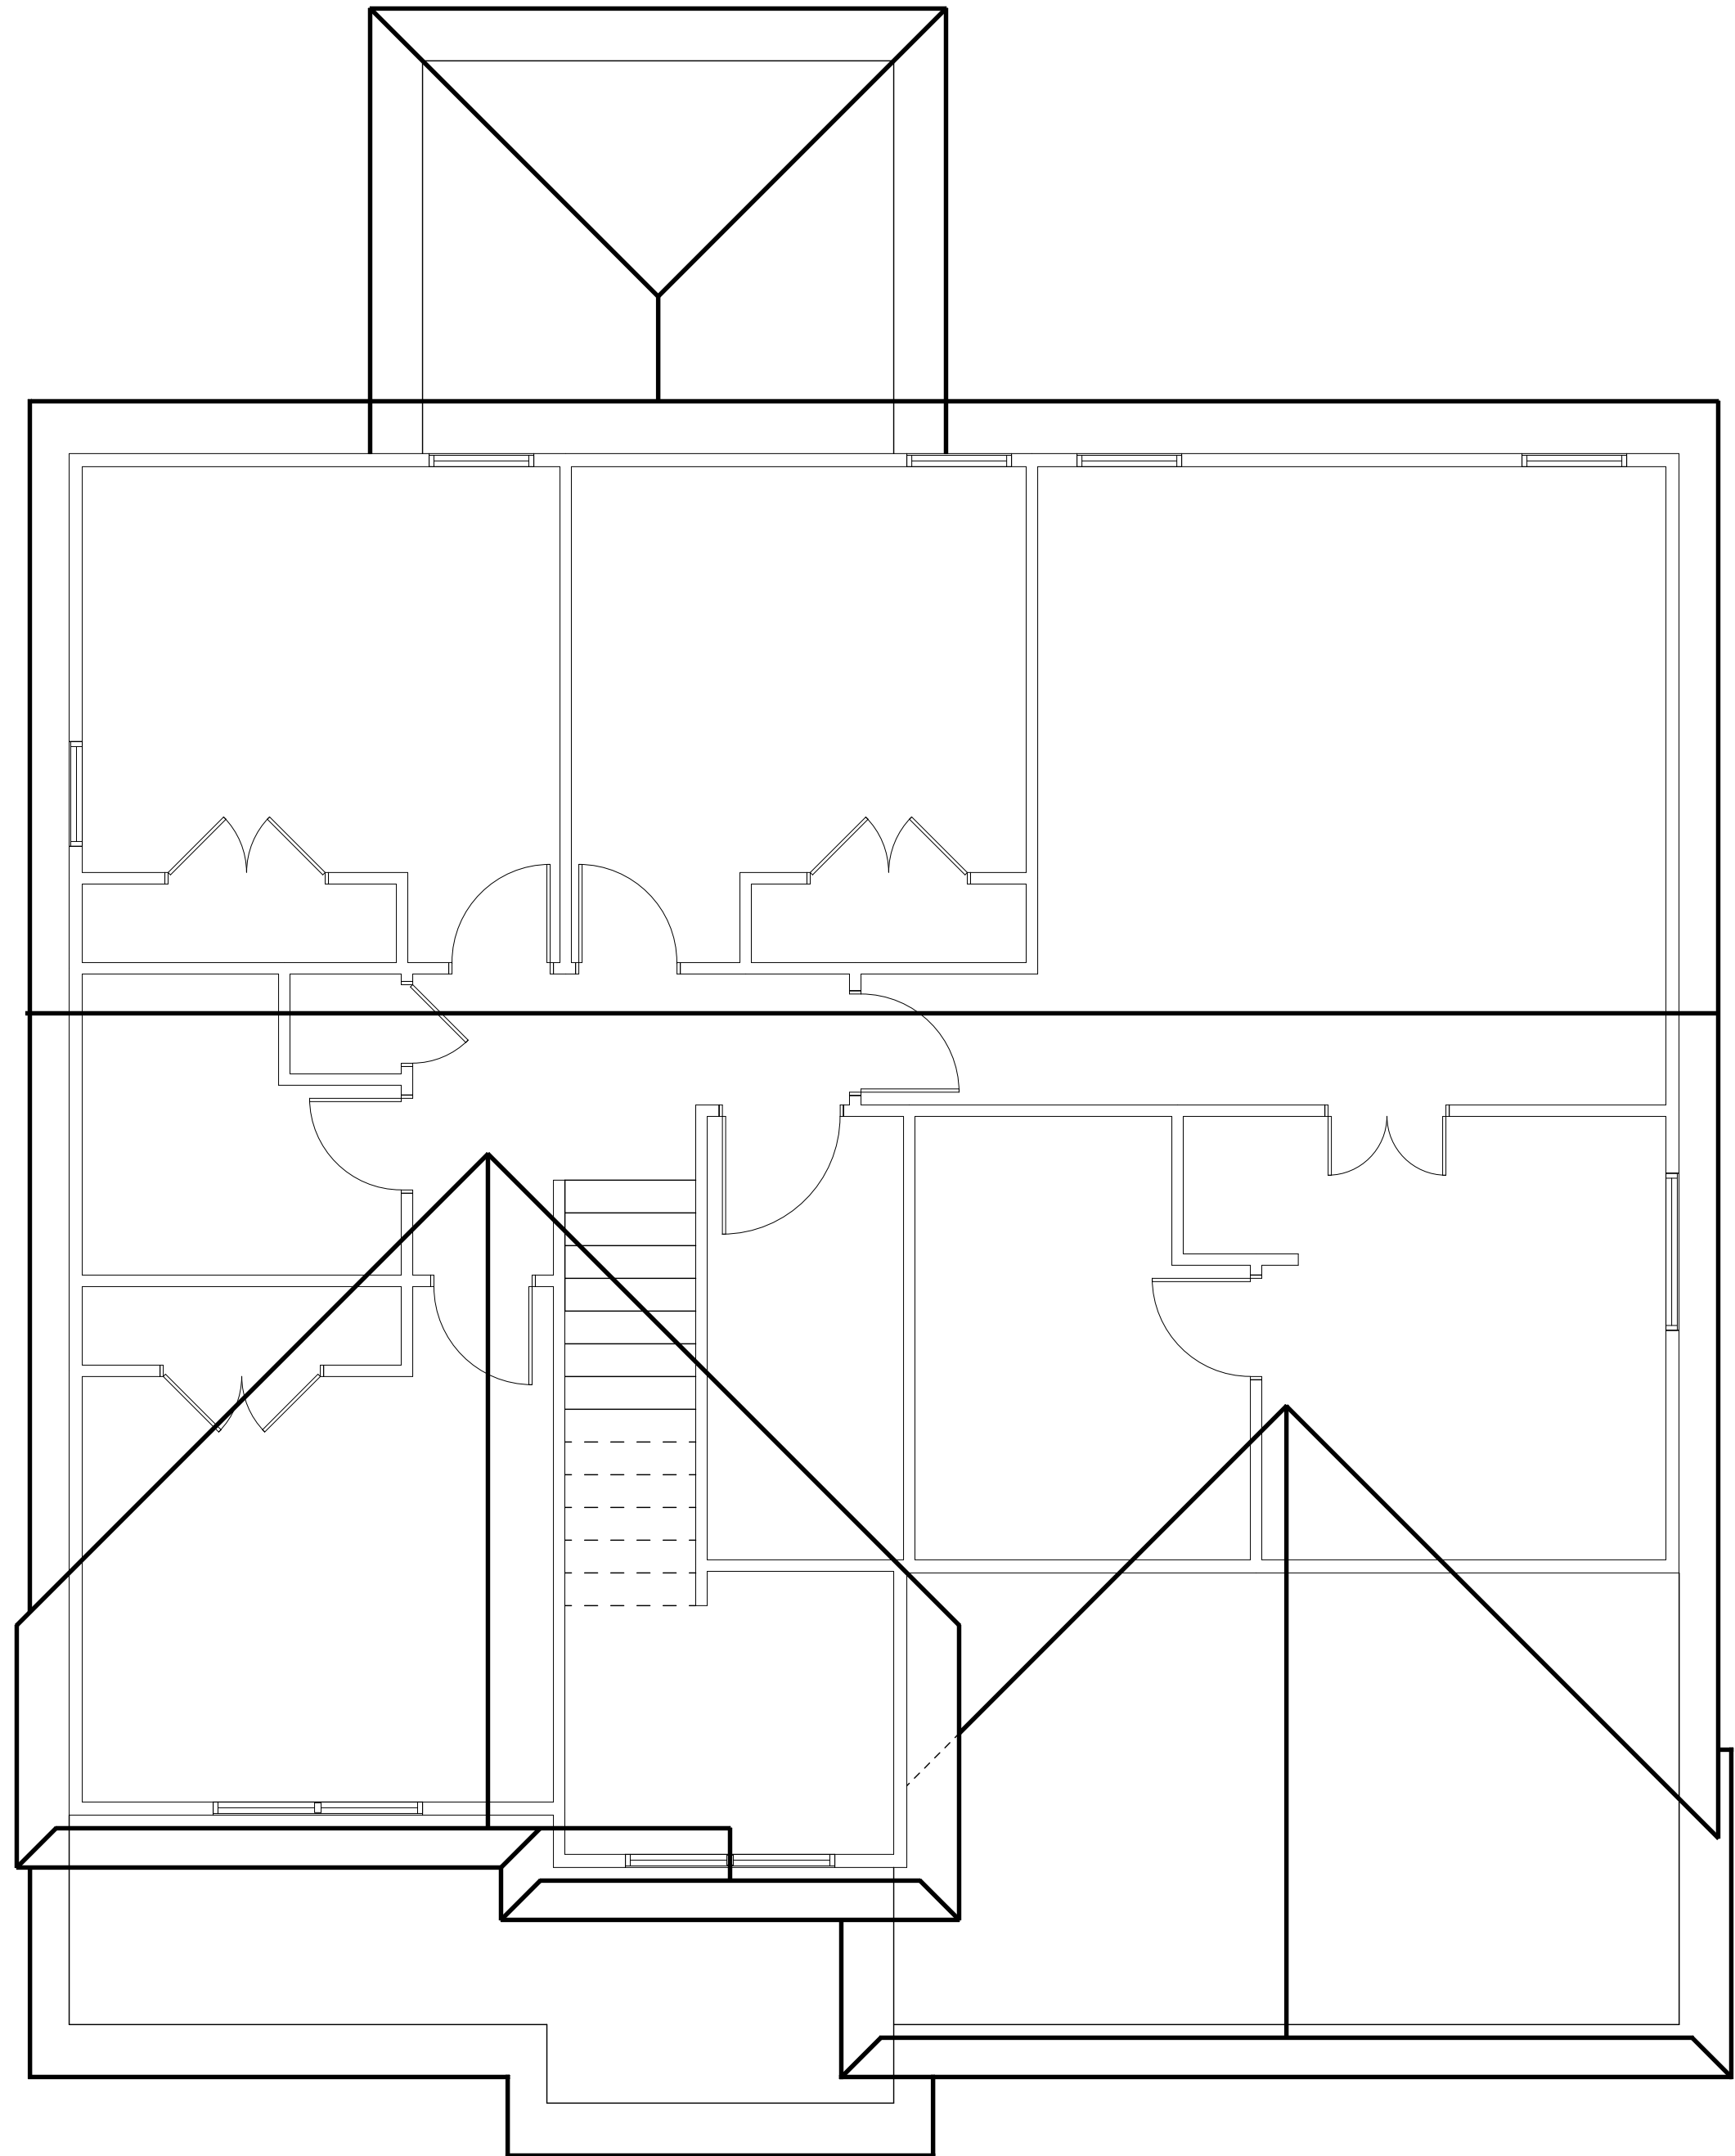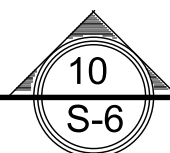

ROOF PLAN
SCALE: 1/4" = 1'-0"


- NOTES:
- UNLESS OTHERWISE NOTED
1. ELECTRICAL PLAN IS INTENDED FOR BID PURPOSES ONLY. ALL WORK SHALL BE DONE IN STRICT ACCORDANCE WITH THE NATIONAL ELECTRIC CODE, LATEST EDITION, BY A LICENSED ELECTRICAL CONTRACTOR WHO SHALL BE RESPONSIBLE FOR THE INSTALLATION & SIZING OF ALL ELECTRICAL, WIRING & ACCESSORIES

2. SMOKE DETECTORS SHALL BE INSTALLED AS DIRECTED BY THE NFPA 72 NATIONAL FIRE ALARM CODE.

3. PROVIDE AFI's (ARC FAULT INTERRUPTERS) IN ALL DWELLING UNIT BEDROOMS PER NEC, SECTION 210-12

4. BATHROOM FANS TO BE VENTED THRU ROOF

ELECTRICAL LEGEND					
SYMBOL	DEFINITION	NOTES	SYMBOL	DEFINITION	NOTES
	110V OUTLET			EXHAUST FAN WITH LIGHT	
	110V OUTLET	EQUIPPED WITH GROUND FAULT INTERRUPTER		FLUORESCENT FIXTURE	
	220V OUTLET			RECESS LIGHTING	
	EXTERIOR WATERPROOF OUTLET			PHONE	
	SWITCH			SMOKE DETECTOR	BATT. BACK-UP W/ HARDWIRE INTER-CONNECTED
	CEILING FAN WITH LIGHT			AIR COND. DISCONNECT	
				METER	

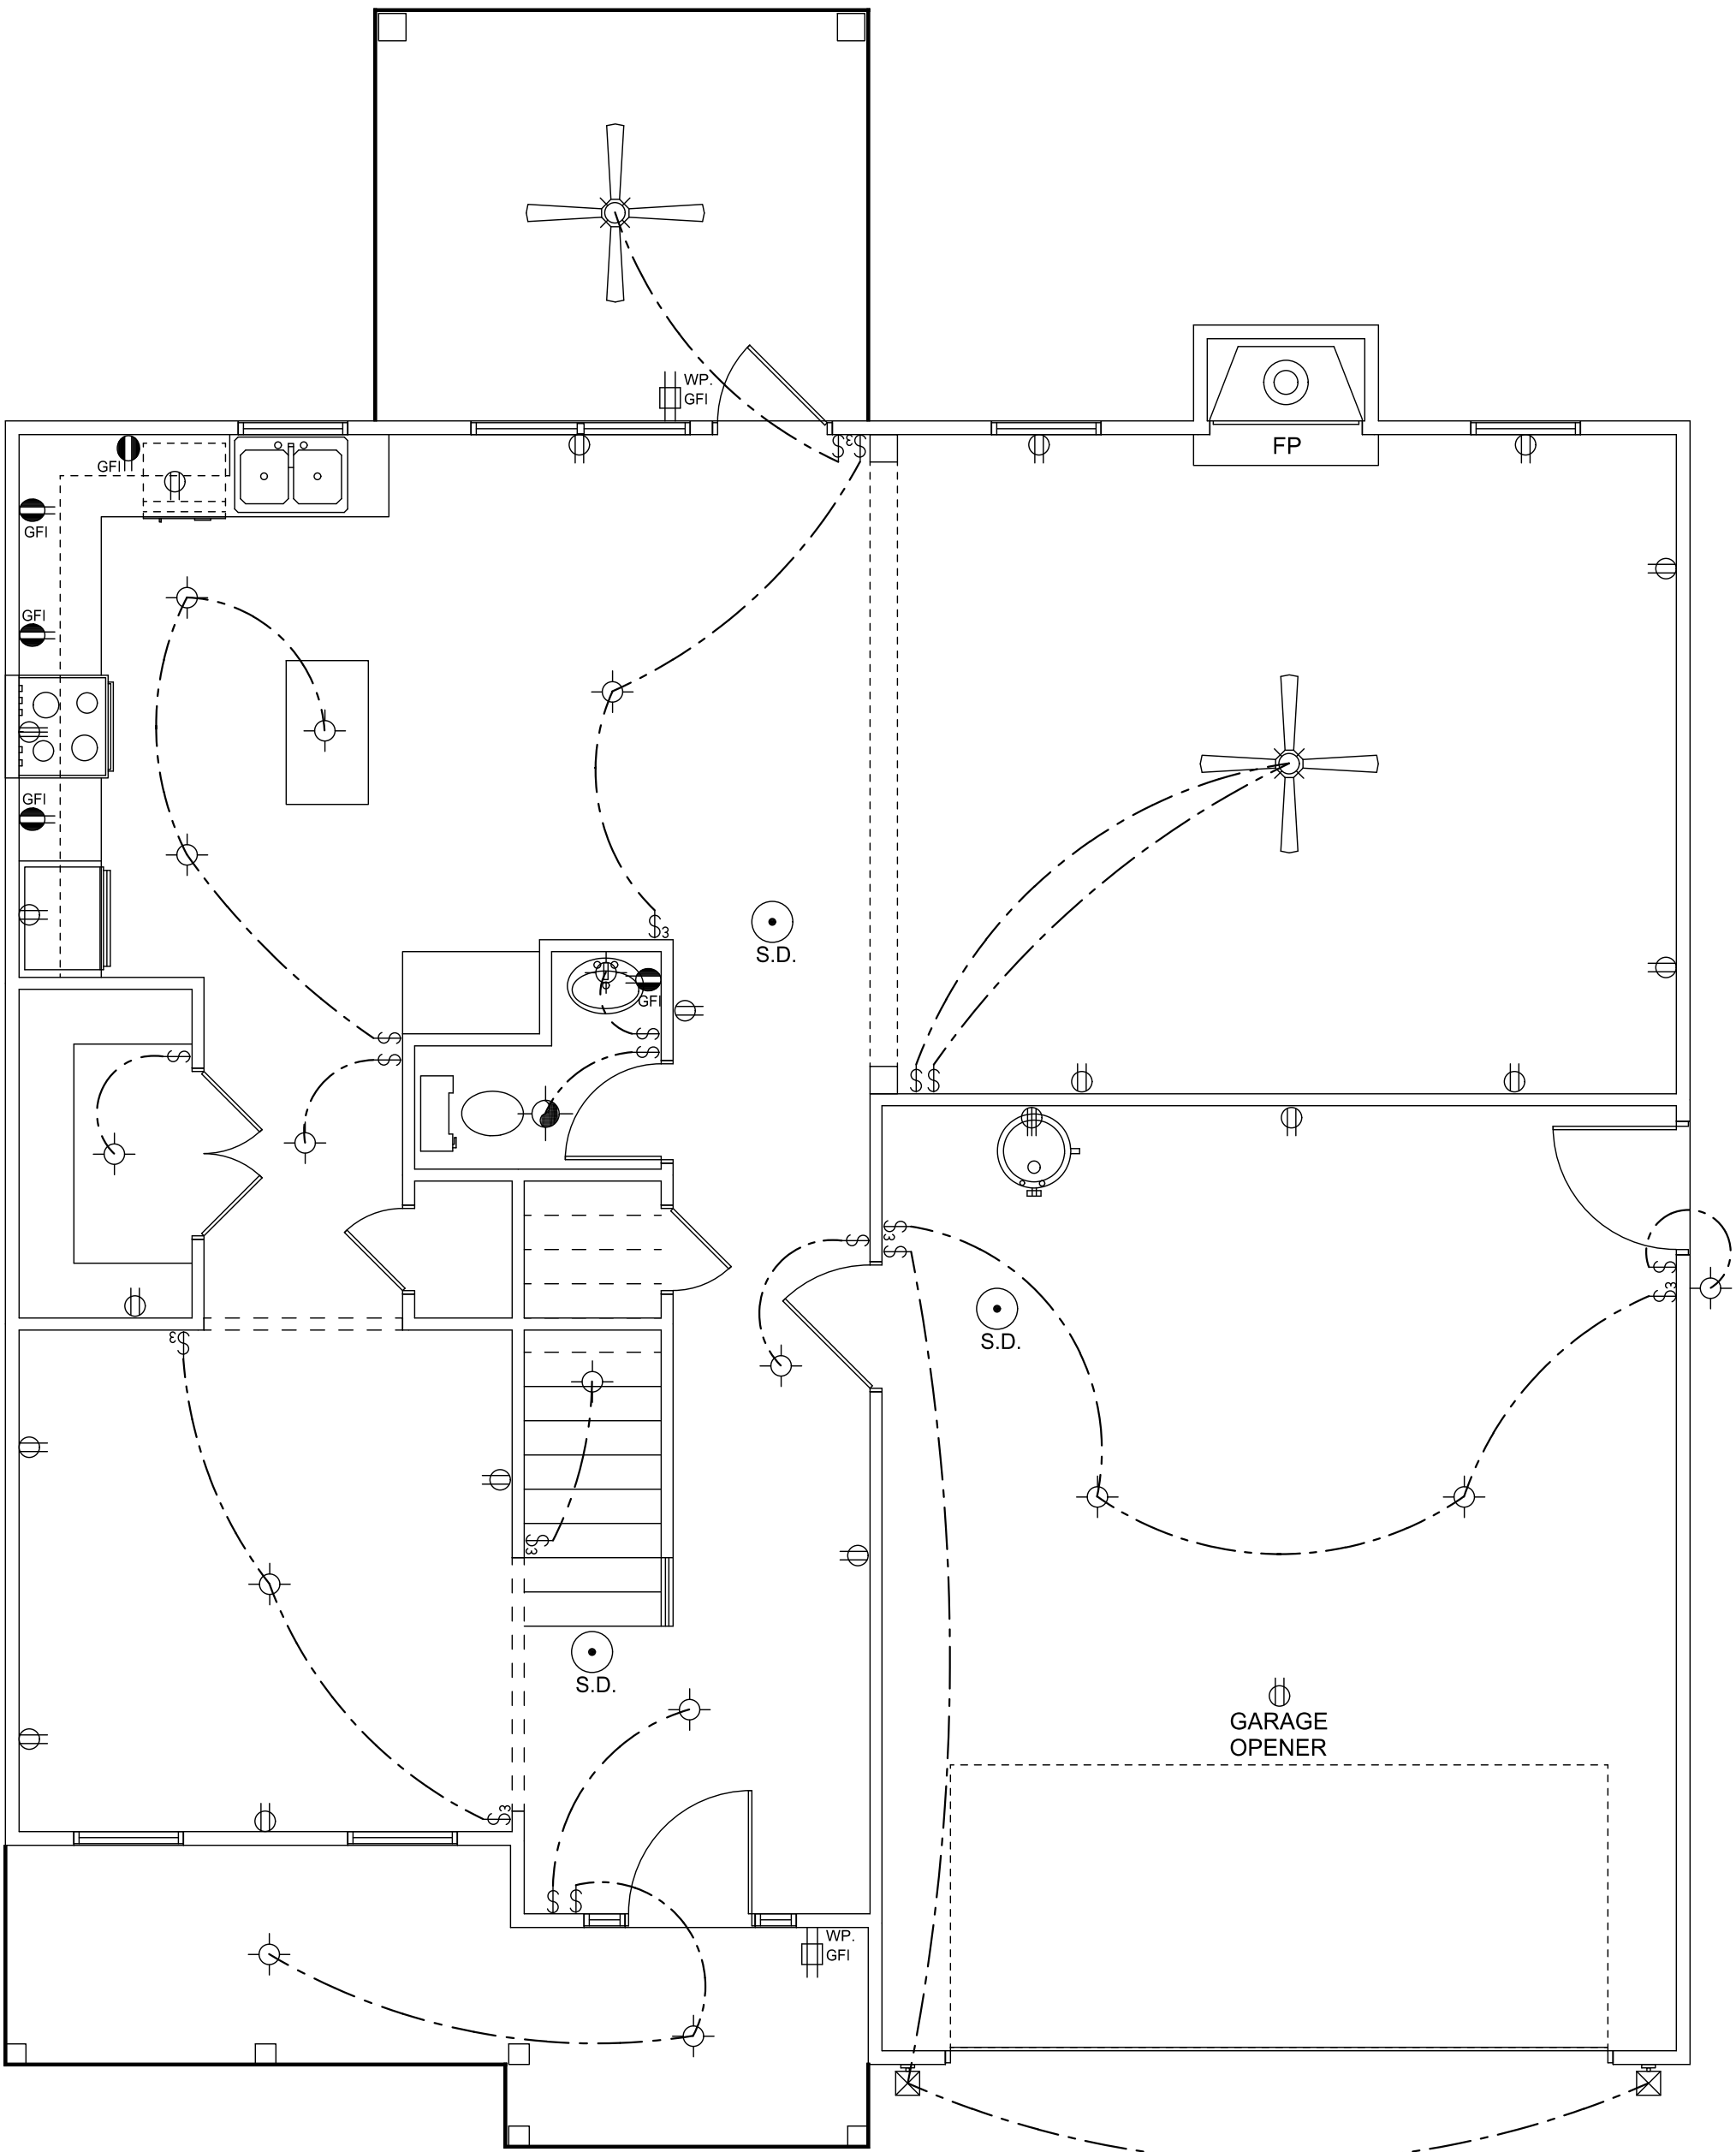


FIRST FLOOR ELECTRICAL PLAN

SCALE: 1/4" = 1'-0"

- NOTES:**
UNLESS OTHERWISE NOTED
1. ELECTRICAL PLAN IS INTENDED FOR BID PURPOSES ONLY. ALL WORK SHALL BE DONE IN STRICT ACCORDANCE WITH THE NATIONAL ELECTRIC CODE, LATEST EDITION, BY A LICENSED ELECTRICAL CONTRACTOR WHO SHALL BE RESPONSIBLE FOR THE INSTALLATION & SIZING OF ALL ELECTRICAL, WIRING & ACCESSORIES
 2. SMOKE DETECTORS SHALL BE INSTALLED AS DIRECTED BY THE NFPA 72 NATIONAL FIRE ALARM CODE.
 3. PROVIDE AFI's (ARC FAULT INTERRUPTERS) IN ALL DWELLING UNIT BEDROOMS PER NEC, SECTION 210-12
 4. BATHROOM FANS TO BE VENTED THRU ROOF

ELECTRICAL LEGEND					
SYMBOL	DEFINITION	NOTES	SYMBOL	DEFINITION	NOTES
	110V OUTLET			EXHAUST FAN WITH LIGHT	
	110V OUTLET	EQUIPED WITH GROUND FAULT INTERRUPTER		FLUORESCENT FIXTURE	
	220V OUTLET			RECESS LIGHTING	
	EXTERIOR WATERPROOF OUTLET			PHONE	
	SWITCH			SMOKE DETECTOR	BATT. BACK-UP W/ HARDWIRE INTER-CONNECTED
	CEILING FAN WITH LIGHT			AIR COND. DISCONNECT	
				METER	

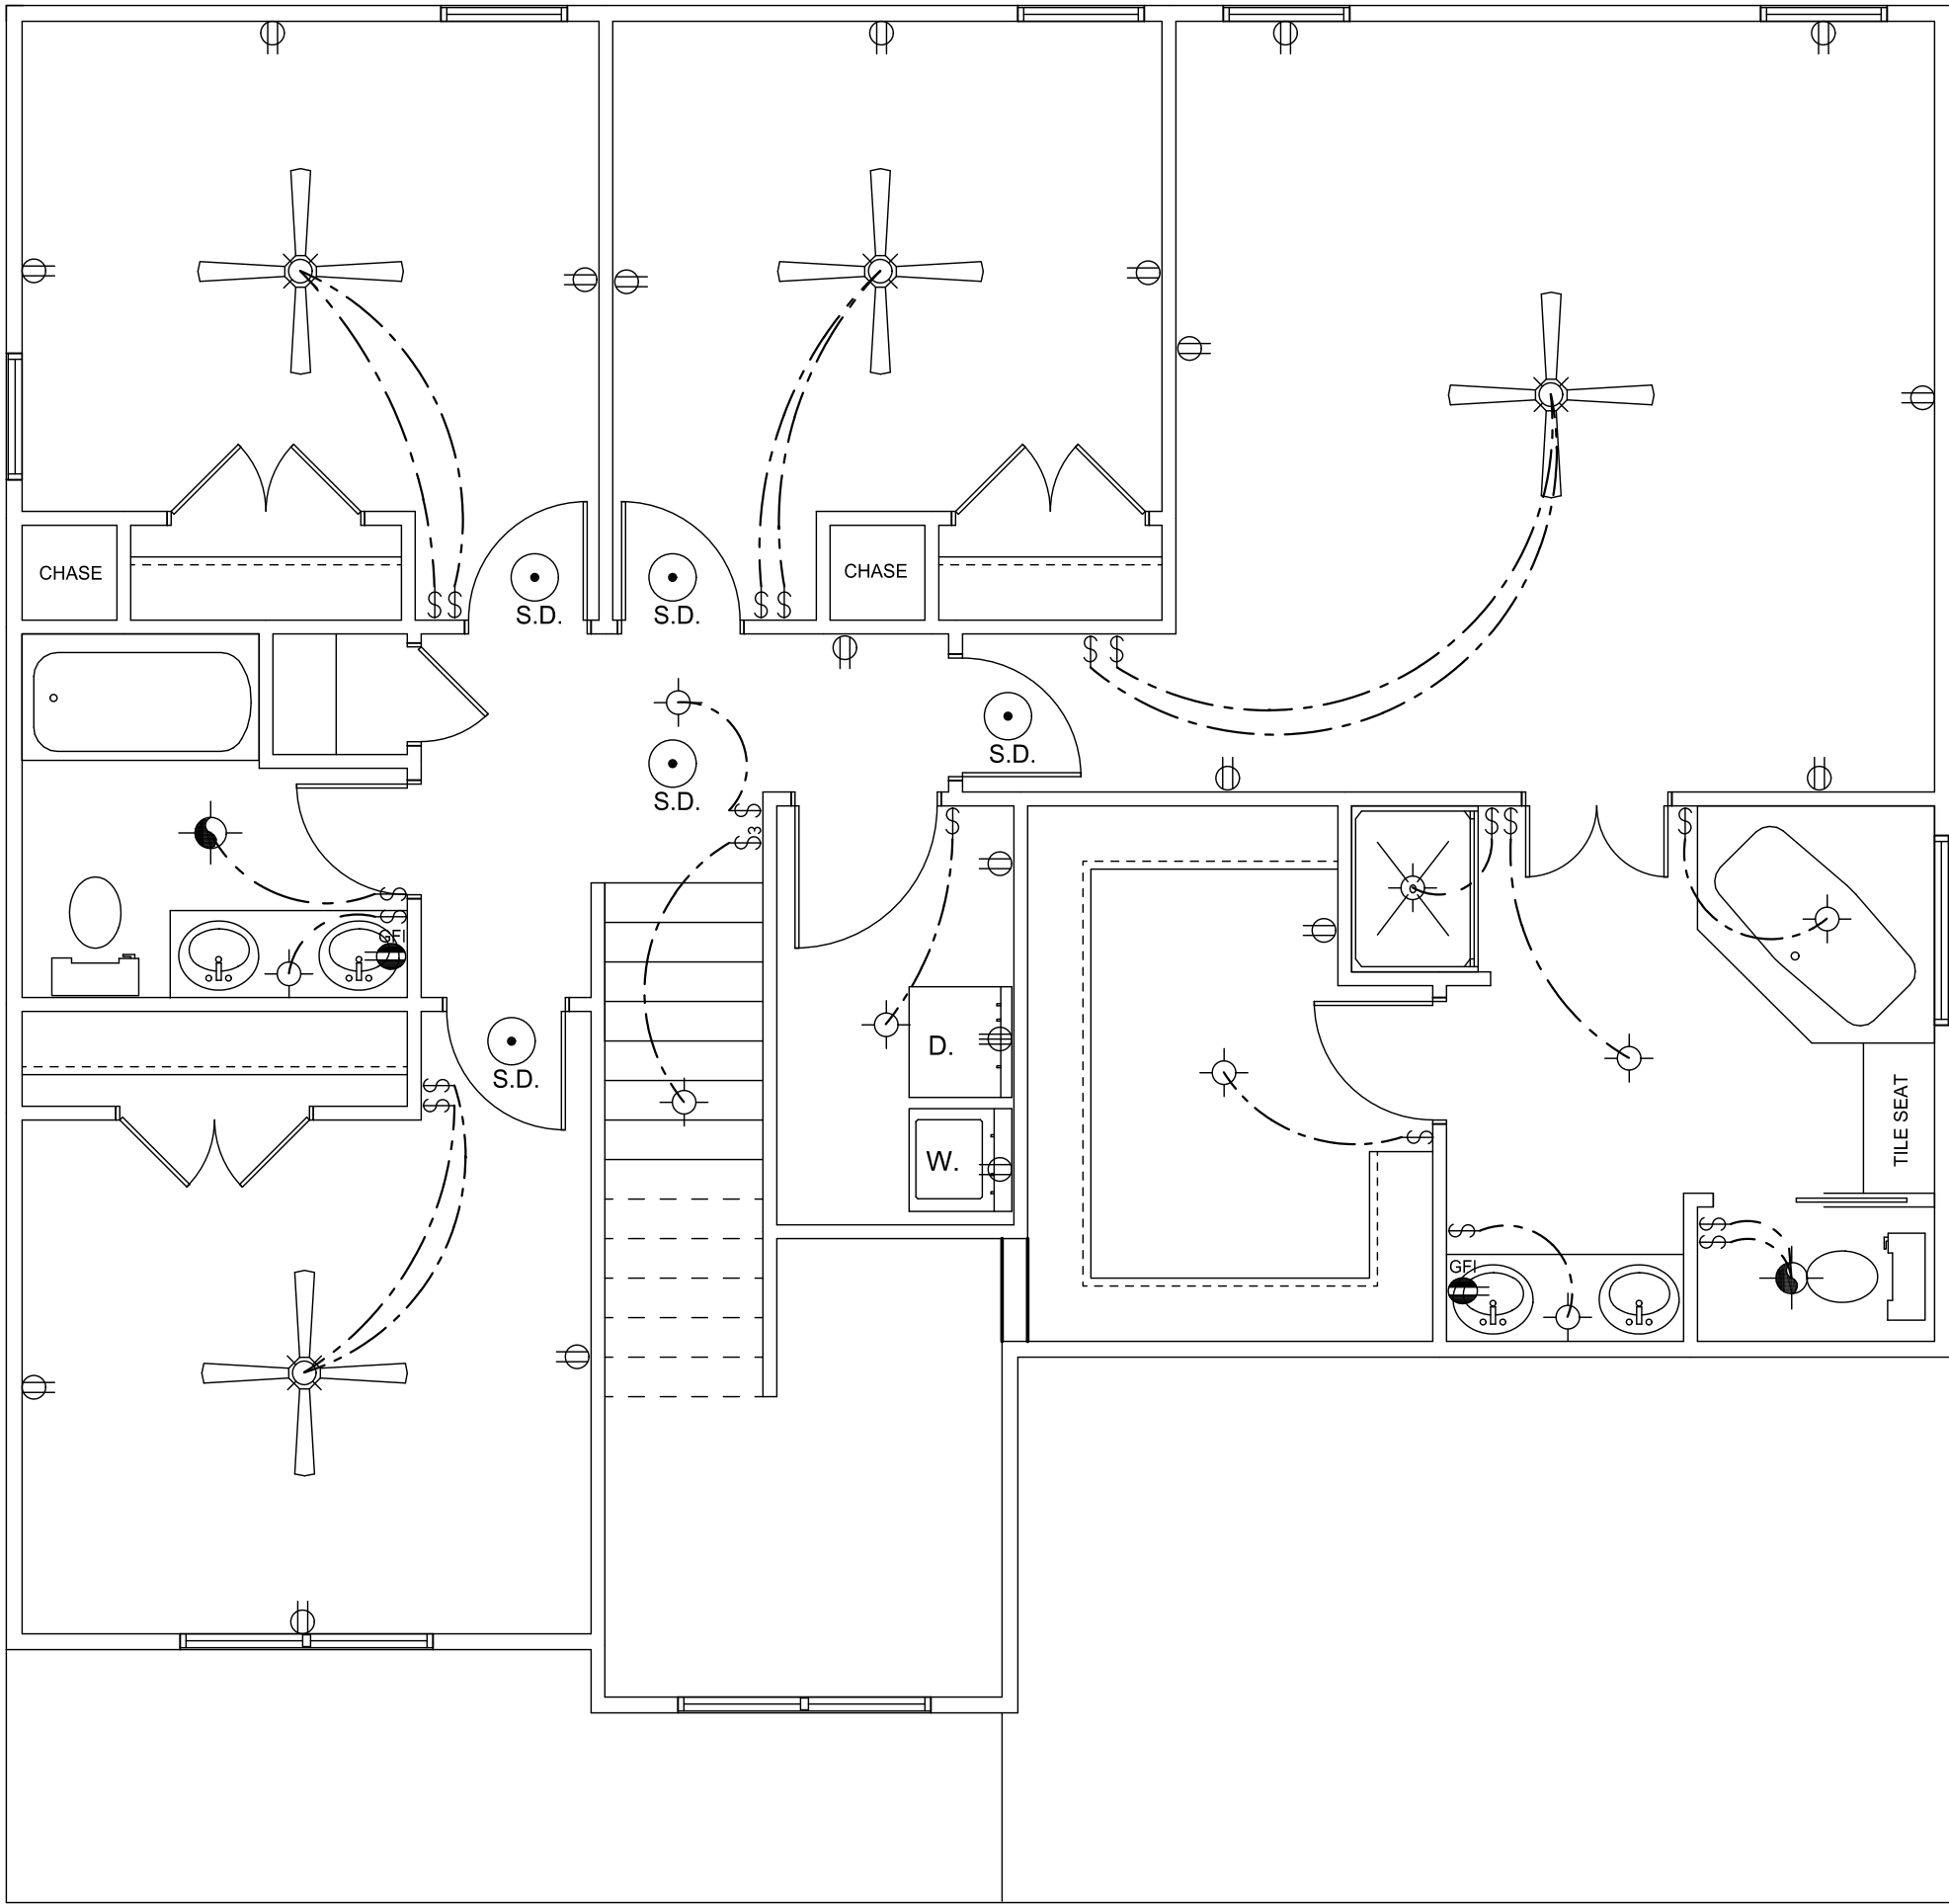

SECOND FLOOR ELECTRICAL PLAN
SCALE: 1/4" = 1'-0"